

[illegible]

CONSULTANT:

[illegible]


PROJECT NO:	267020
DRAWN BY:	BTF
CHECKED BY:	MBS

SHEET NAME

FIRE PROTECTION FLOOR
PLAN

SEAL	SHEET NUMBER
------	--------------

DESIGN CRITERIA ONLY NOT FOR CONSTRUCTION	SHEET NUMBER EP101
---	----------------------------------

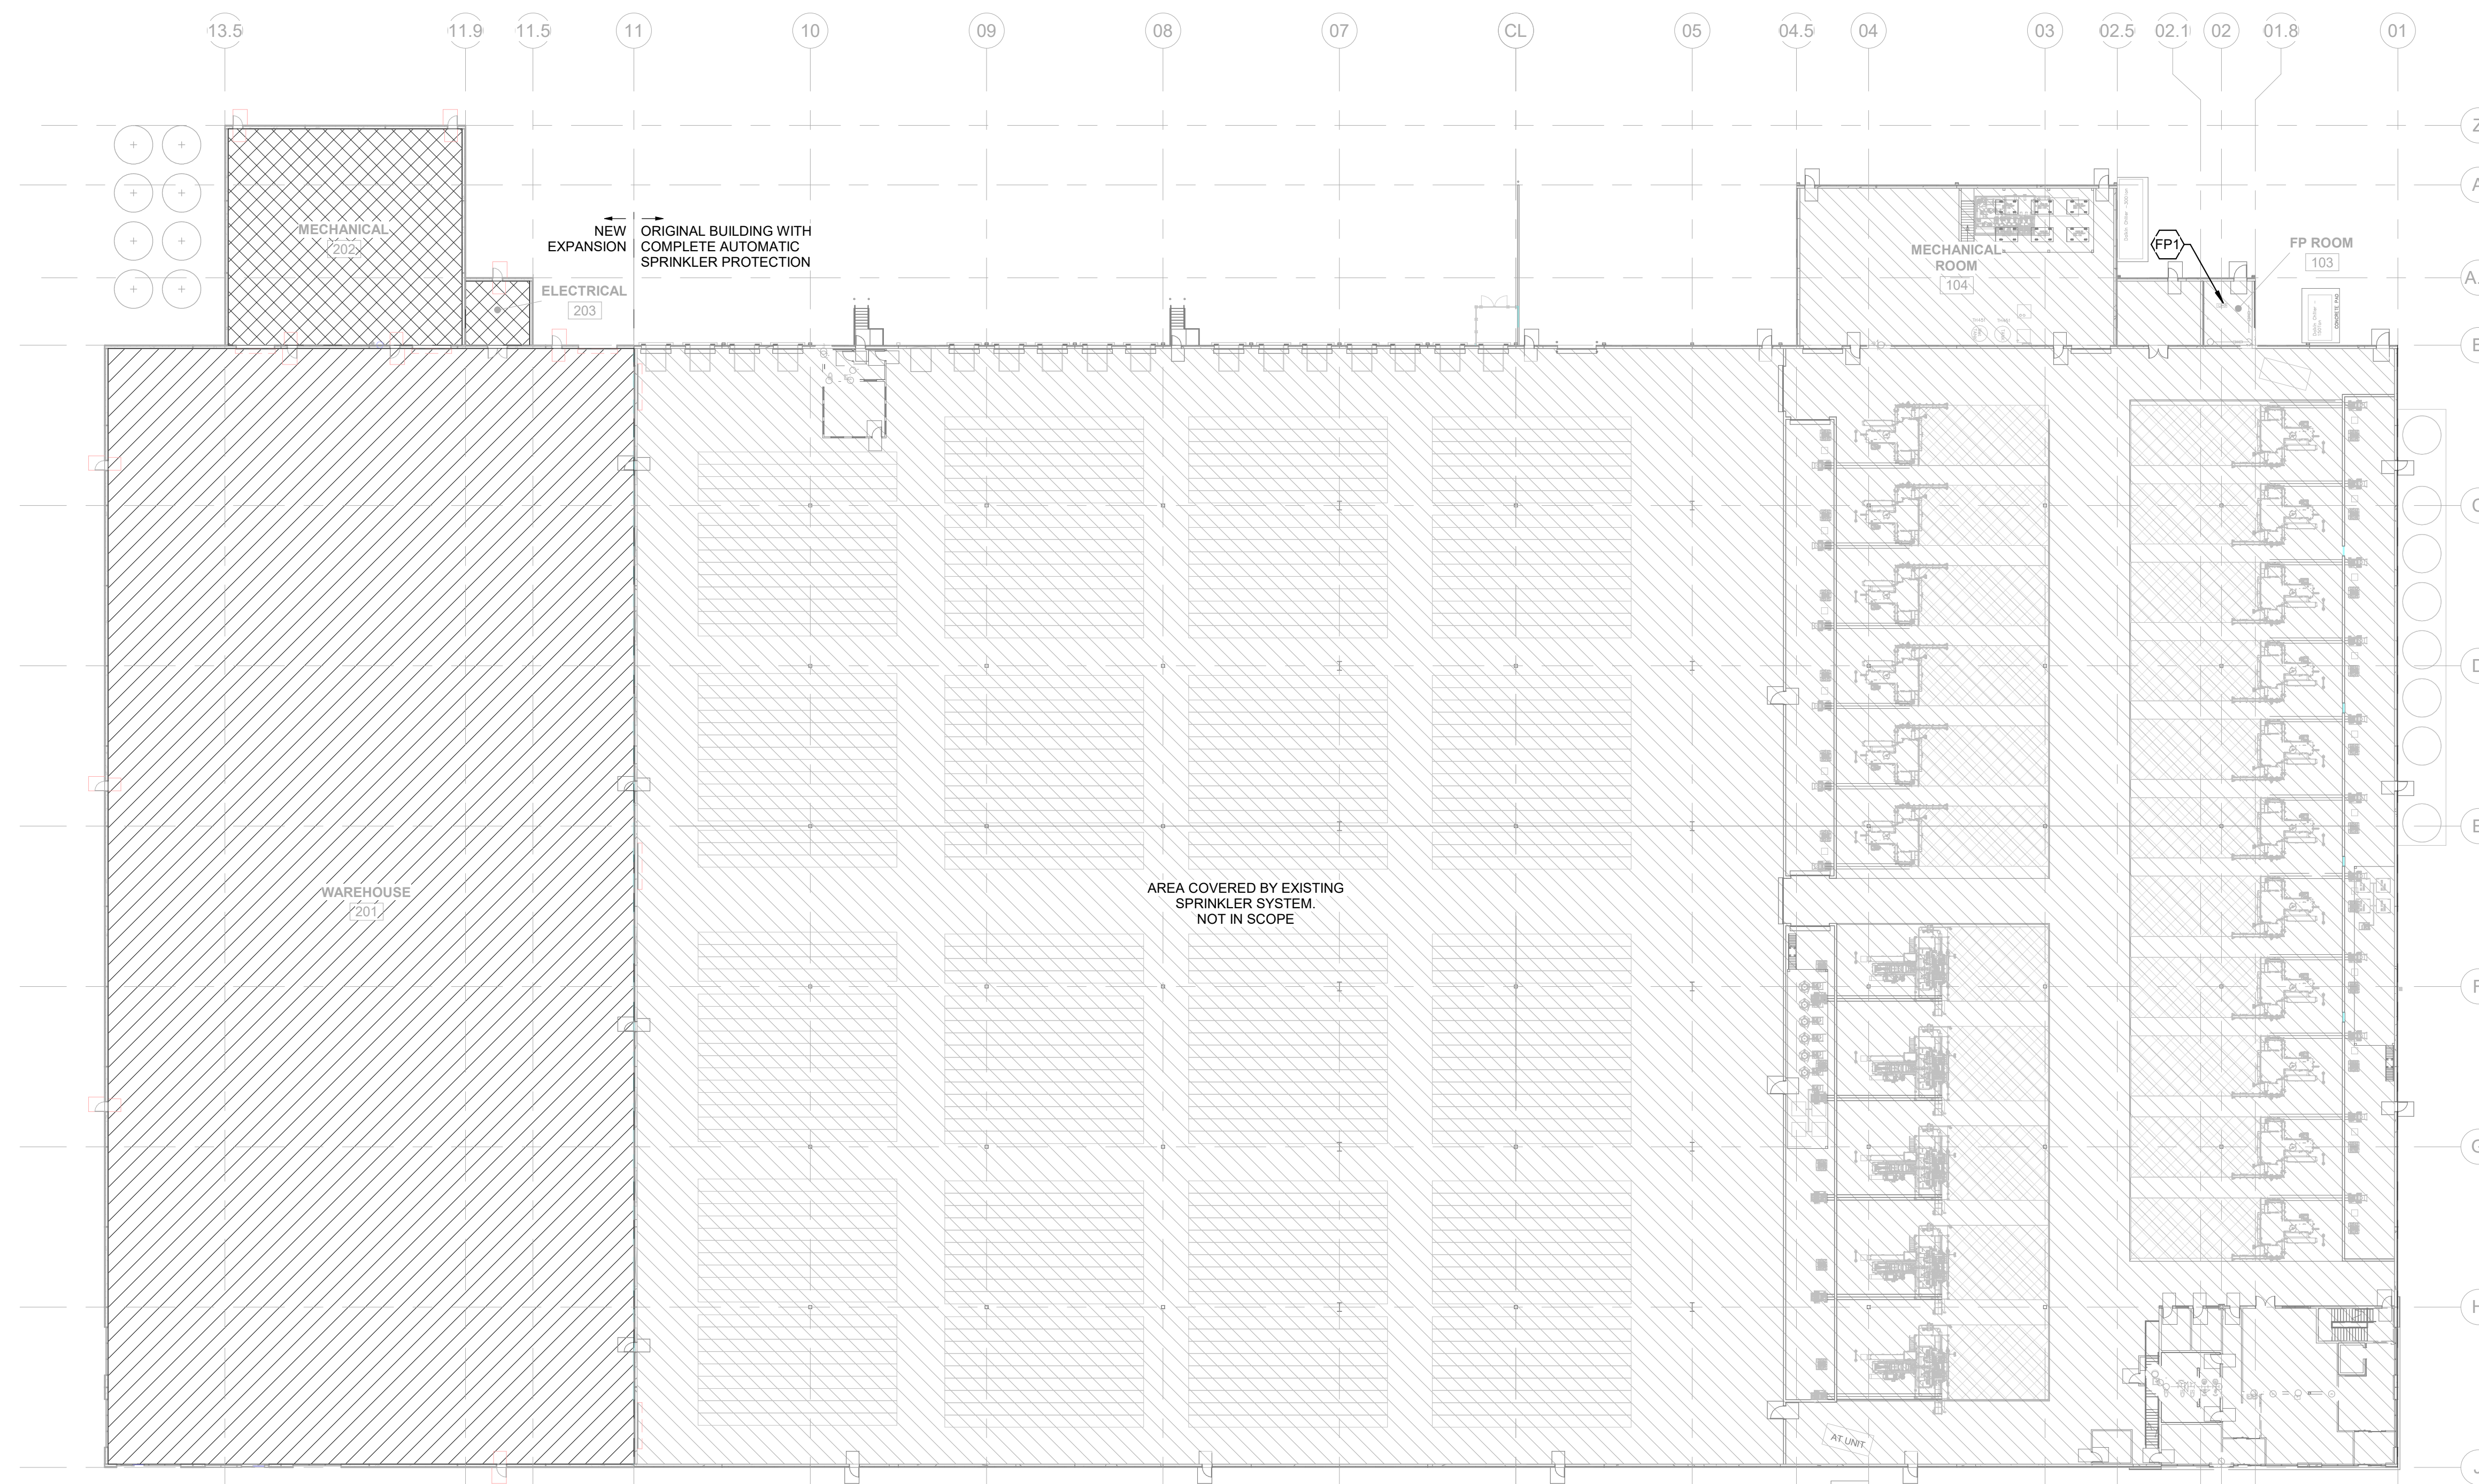

1 FIRE PROTECTION FIRST FLOOR PLAN
1/32" = 1'-0"

GENERAL SHEET NOTES

- | |
|---|
| <p>A. THIS FIRE PROTECTION PLAN IS FOR SCHEMATIC PURPOSES ONLY. REFER TO CIVIL DRAWINGS FOR PROPOSED LOCATION OF FIRE HYDRANTS, POST INDICATOR VALVES, ETC.</p> <p>B. FINAL RISER LOCATIONS TO BE COORDINATED WITH ARCHITECT AND ALL OTHER TRADES. FP ZONES ARE NOT TO EXCEED 40,000 SQUARE FEET IN AREA.</p> <p>C. FIRE PUMP AND ALL ASSOCIATED EQUIPMENT SHALL BE INSTALLED IN ACCORDANCE WITH NFPA 20.</p> <p>D. INSTALLATION OF STATIONARY PUMPS FOR FIRE PROTECTION.</p> <p>E. FP CONTRACTOR TO DETERMINE IF FIRE PROTECTION WATER STORAGE TANK IS REQUIRED BASED ON WATER PRESSURE TEST TO BE OBTAINED BY FP CONTRACTOR. WATER STORAGE TANKS SHALL BE INSTALLED IN ACCORDANCE WITH NFPA 22. WATER TANKS FOR PRIVATE FIRE PROTECTION.</p> <p>F. FP CONTRACTOR TO COORDINATE ANY STRUCTURAL REQUIREMENTS AND PIPE BRACING WITH STRUCTURAL ENGINEER.</p> <p>G. THE WATER MAIN SERVING THE FIRE SPRINKLER SYSTEM IS TO BE FLUSHED OUT, AT A RATE APPROPRIATE FOR ITS SIZE, PRIOR TO CONNECTION TO THE SYSTEM. NOTIFY THE LOCAL AUTHORITY TWENTY FOUR (24) HOURS IN ADVANCE OF THE FLUSHING TO WITNESS.</p> <p>H. ENSURE SPRINKLER PIPING DOES NOT BREACH MINIMUM 36' CLEAR HEIGHT IN WAREHOUSE.</p> |
|---|

SHEET KEYNOTES

FP1 EXISTING FIRE PUMP

DRAWING INFORMATION

